


**ELECTRICAL
FLOOR PLAN
SCALE 1:100**

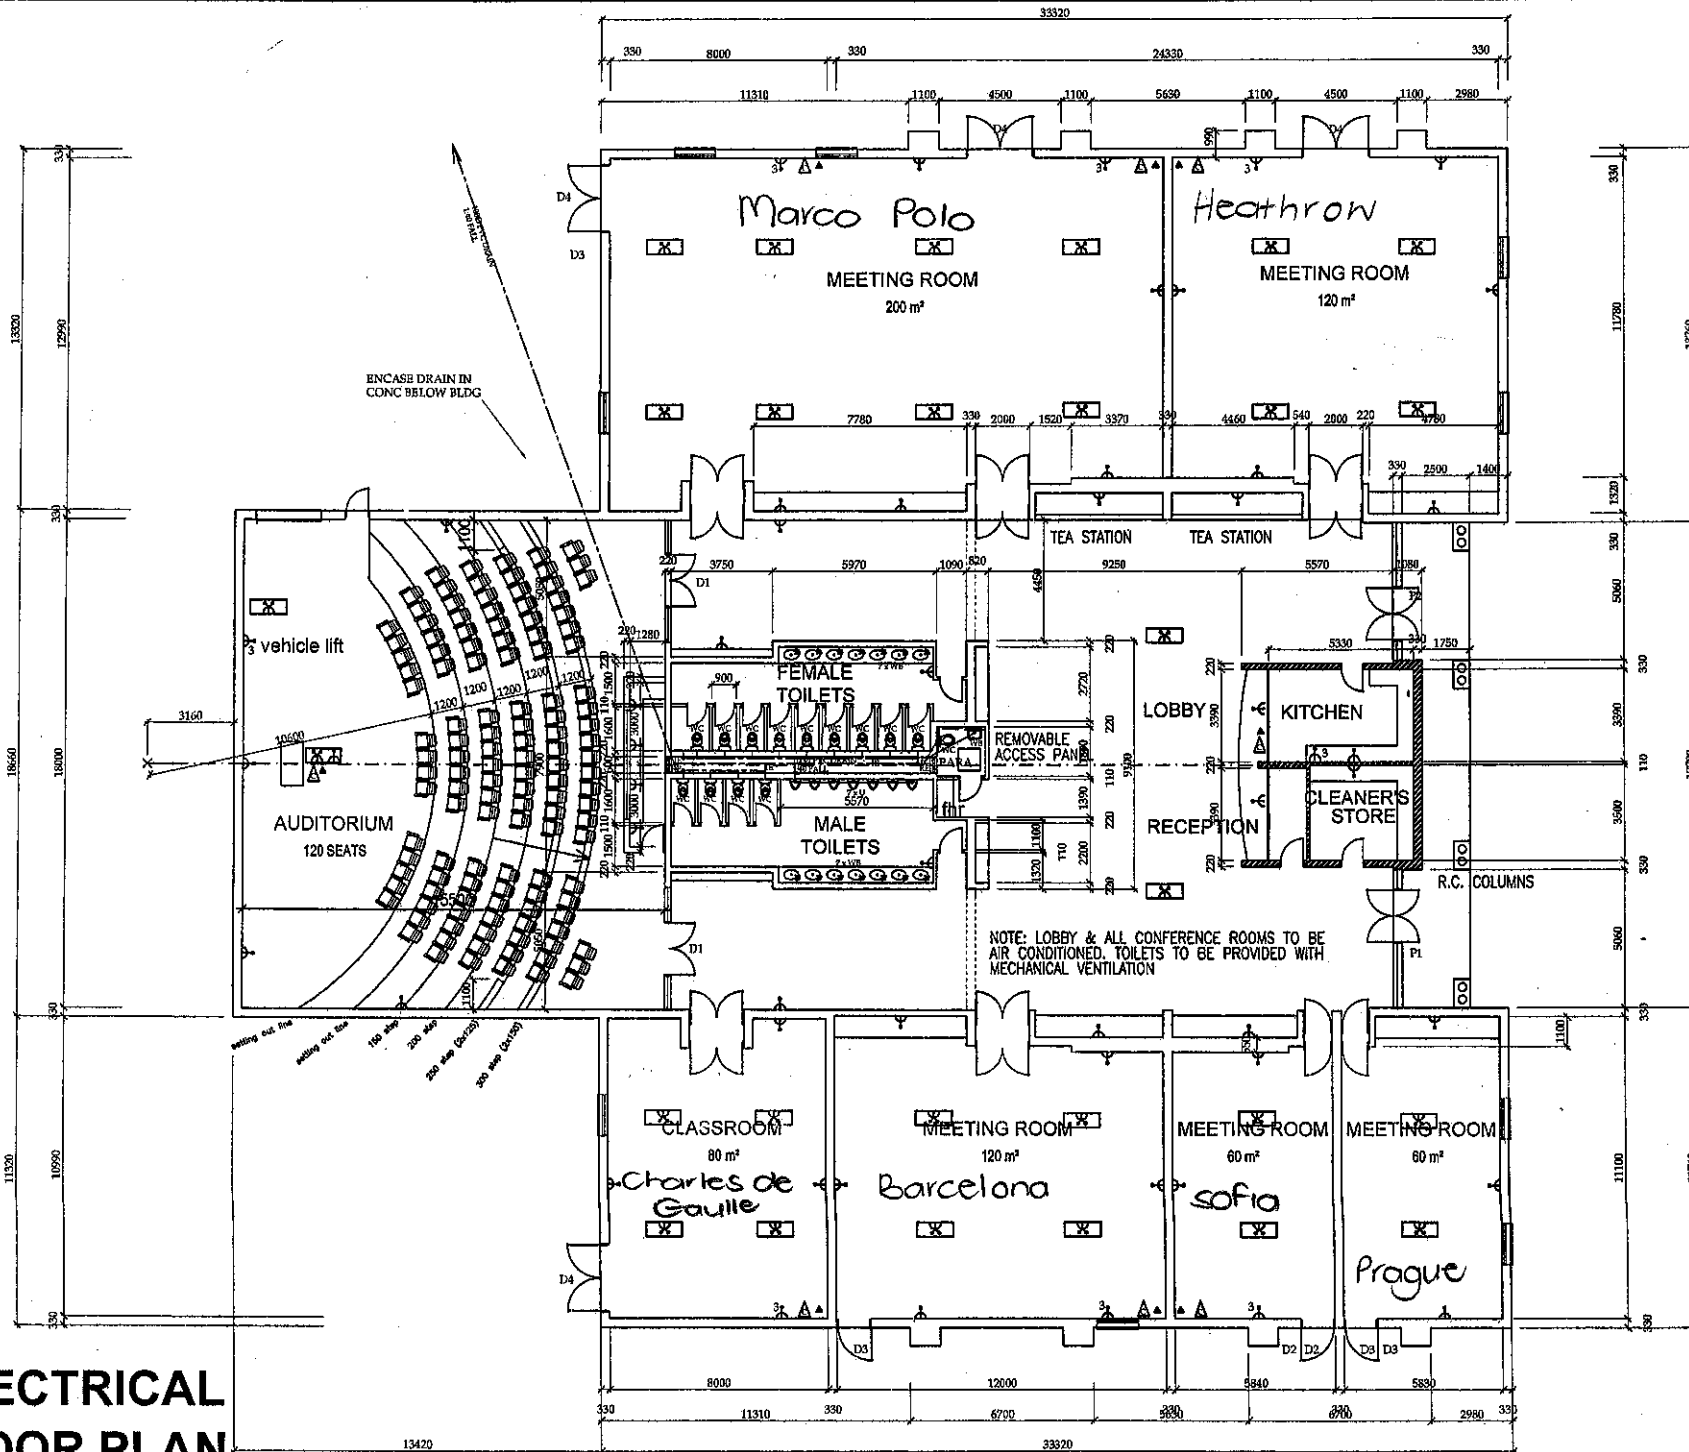

ELECTRICAL LEGEND	
	DOUBLE IN/OFF SWITCH/FUS
	SINGLE IN/OFF SWITCH/FUS
	FLOOR MOUNTED PLUG PANEL
	6P TELEPHONE OUTLET
	COMPUTER OUTLET
	5P POWER OUTLET

International Centre

L. M. H. DESIGNS
 PROFESSIONAL SENIOR
 ARCHITECTURAL TECHNOLOGIST
 S.A.C.A.P.
 REGISTRATION NO ST1280
 L. HOCKLY
 P.O. BOX 164470 BURNBARD PARK 1470
 PHOENIX 318 0414 TEL: 081 054 9833

AREA:
 GROUND FLOOR 1633m²
 COVERED PORCH 38msq
 TOTAL 1671msq

OWNER SIGNATURE

CLIENT
 CLOVERS GREEN INVESTMENTS
 BIRCHWOOD HOTEL PROPOSED
 MOTOR CONFERENCE CENTER
 ON BARDENE EXT 75

DRAWING NO E2209.12.6.2	DATE OCT 06	BY L. HOCKLY	SCALE 1:100
----------------------------	----------------	-----------------	----------------

BUILDING 2 - MOTOR ORIENTED FACILITIES