

MUNICIPAL APPROVAL

ELECTRICAL LEGEND

X	POWER TO WATER TREATMENT PLANT
←	TRUCKS TO WATER TREATMENT PLANT
□	TRUCKS TO WATER TREATMENT PLANT
▲	TRUCKS TO WATER TREATMENT PLANT
▲	TRUCKS TO WATER TREATMENT PLANT
⊖	TRUCKS TO WATER TREATMENT PLANT

L. M. H. DESIGNS
 PROFESSIONAL SENIOR
 ARCHITECTURAL TECHNOLOGIST

S.A.C.A.P.
 REGISTRATION NO ST1300

1000 WEST 141ST AVENUE SUITE 1107
 FORT WORTH, TEXAS 76140
 PHONE 817 345 1100 FAX 817 345 1101

AREA:


GROUND FLOOR	5566msq
COVERED PORCH	233msq
FIRST FLOOR	220msq
TOTAL	6019msq

OWNER SIGNATURE

CLIENT
 CLOVERS GREEN INVESTMENTS

BIRCHWOOD HOTEL PROPOSED
 MAIN CONFERENCE CENTER
 ON ERF 75 BARDENE EXT 75

DATE: 20/05/2014
 DRAWN BY: M. L. HODDLY
 CHECKED BY: M. L. HODDLY
 SCALE: 1:200

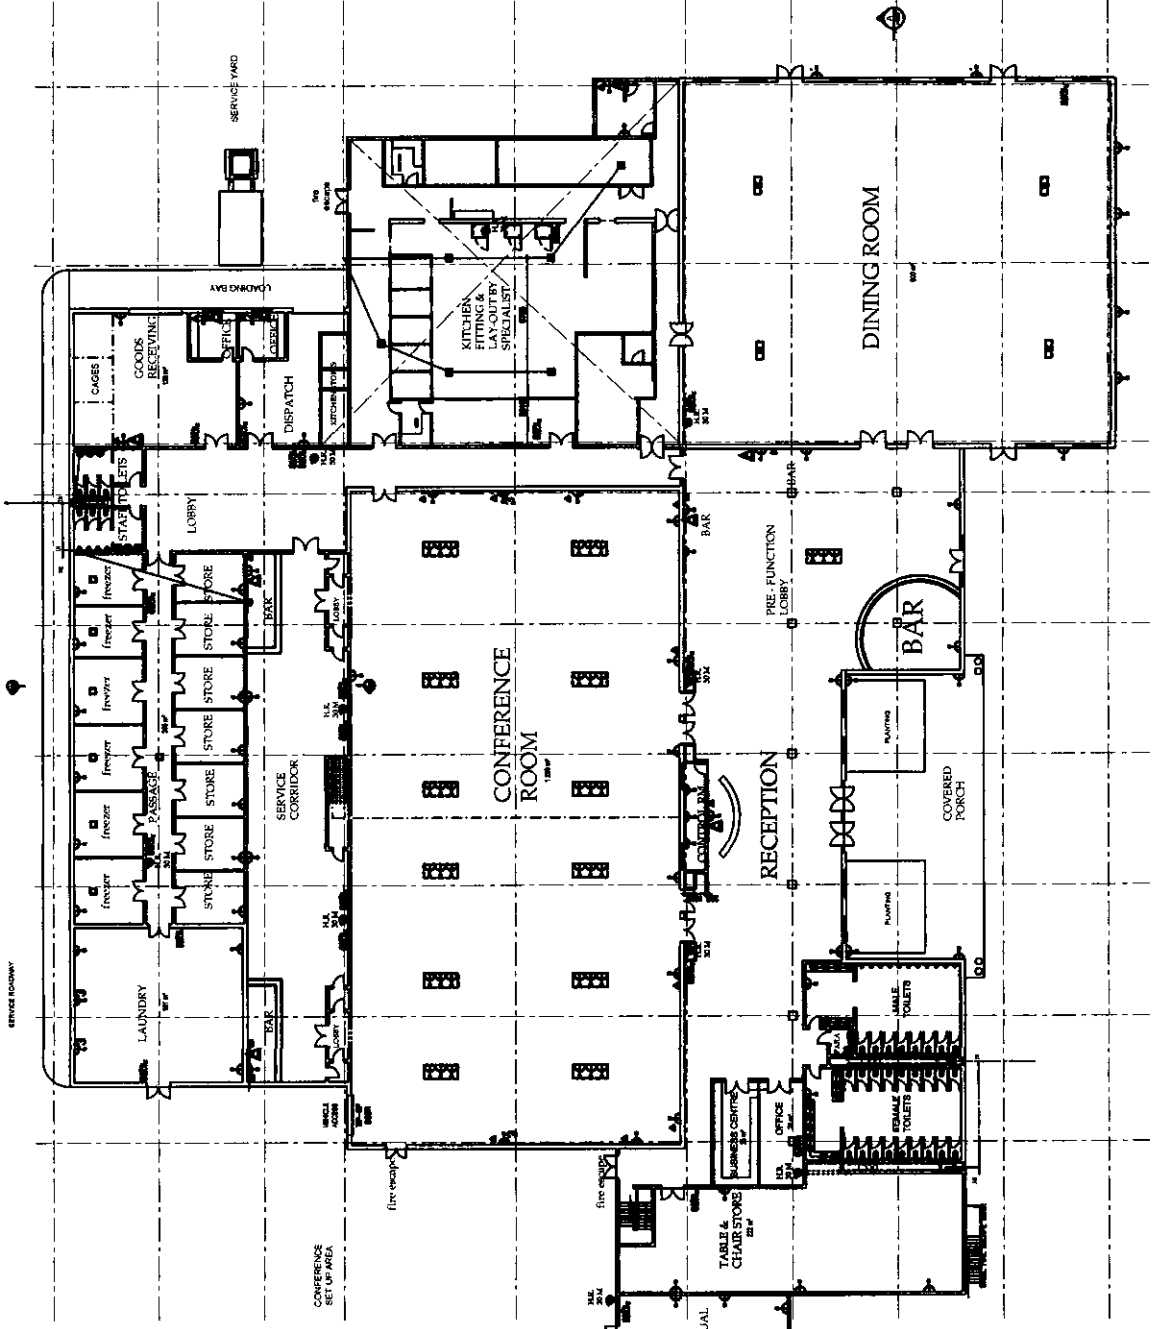

FLOOR PLAN
 SCALE 1:200



FIRST FLOOR
 SCALE 1:200

BUILDING 3 -
 MAIN CONFERENCE
 FACILITIES
 ELECTRICAL LAY-OUT